




FIRE WATER LINE 8 IN

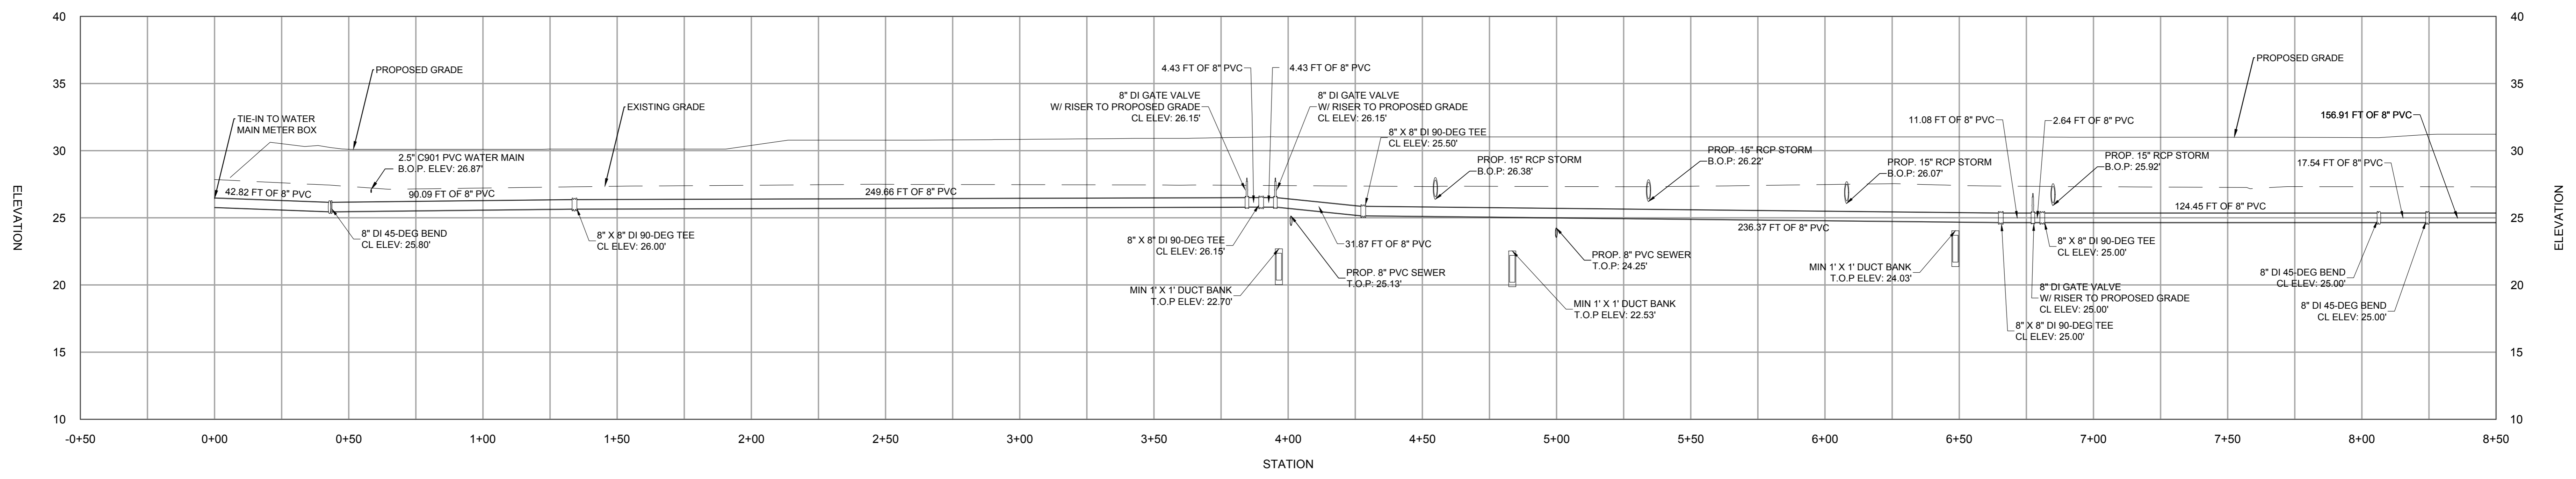

FIRE WATER LINE 8 IN

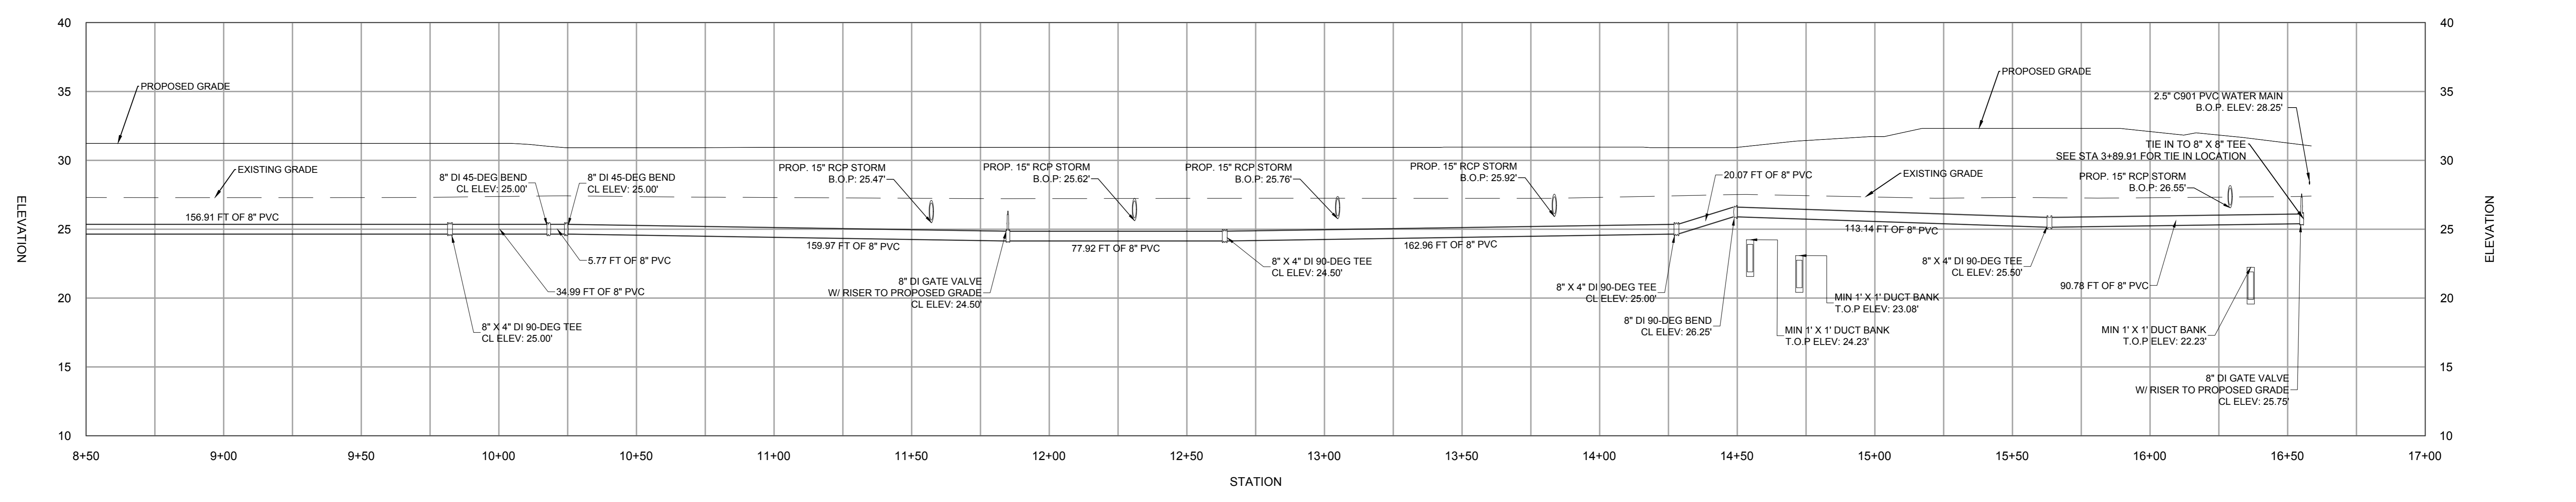

C:\Users\WRAGHC\OneDrive - Jacobs\Desktop\Projects\Gumbo\PERMIT\UPDATE\ES\240.dwg 6/19/2025 10:43 AM

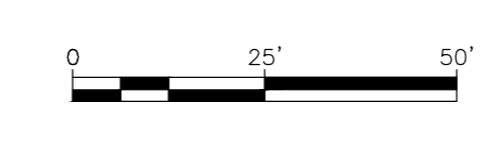

REVISIONS		
NO.	DATE	DESCRIPTION
1.0	2025-06-20	TECHNICAL SITE PLAN APPLICATION
2.0	2025-09-15	TECHNICAL SITE PLAN - 2ND SUBMISSION

Drawn By: CEW
Approved By: MG
Design Team: Civil

GUMBO
PROJECT ADDRESS:
1035 TOWN CENTER BLVD,
PALM COAST, FL 32164
Project Number: K4018368

FIRE WATER MAINLINE
Discipline: CIVIL
Scale: 1"=25'
Sheet Size: A0 - 33.1" x 46.8"

Sheet Number: **C-241**
Current Rev: 1.0
Phase: TECHNICAL SITE PLAN APPLICATION
Model Name: GUMBO-CIVIL
Native File Format: Autodesk Civil 3D 2022